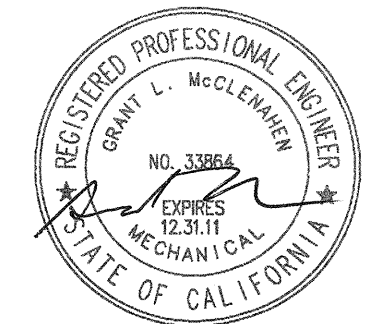


NO.	ISSUES/REVISIONS	DATE
100%	CRITERIA DESIGN	06/07/2010
50%	DETAILED DESIGN	12/02/2010
100%	DETAILED DESIGN	12/21/2010
50%	IMPLEMENTATION DOCUMENTS	01/14/2011
100%	IMPLEMENTATION DOCUMENTS	02/04/2011
100%	IMPLEMENTATION DOCUMENTS	02/04/2011
100%	IMPLEMENTATION DOCUMENTS	02/04/2011
100%	IMPLEMENTATION DOCUMENTS	02/04/2011
100%	IMPLEMENTATION DOCUMENTS	02/04/2011
100%	IMPLEMENTATION DOCUMENTS	02/04/2011


NORTHBAY MEDICAL CENTER
CATH LAB RENOVATION II

OSHPD NO. HS101511-48

KEY PLAN

PROJECT NO.: 09017.01 DRAWN BY:
DATE: 06/07/2010 CHECKED BY:SCALE:
SHEET TITLE:CATH LAB PLUMBING PLAN
PHASE 3 DEMOLITION

SHEET NO.: P2.5

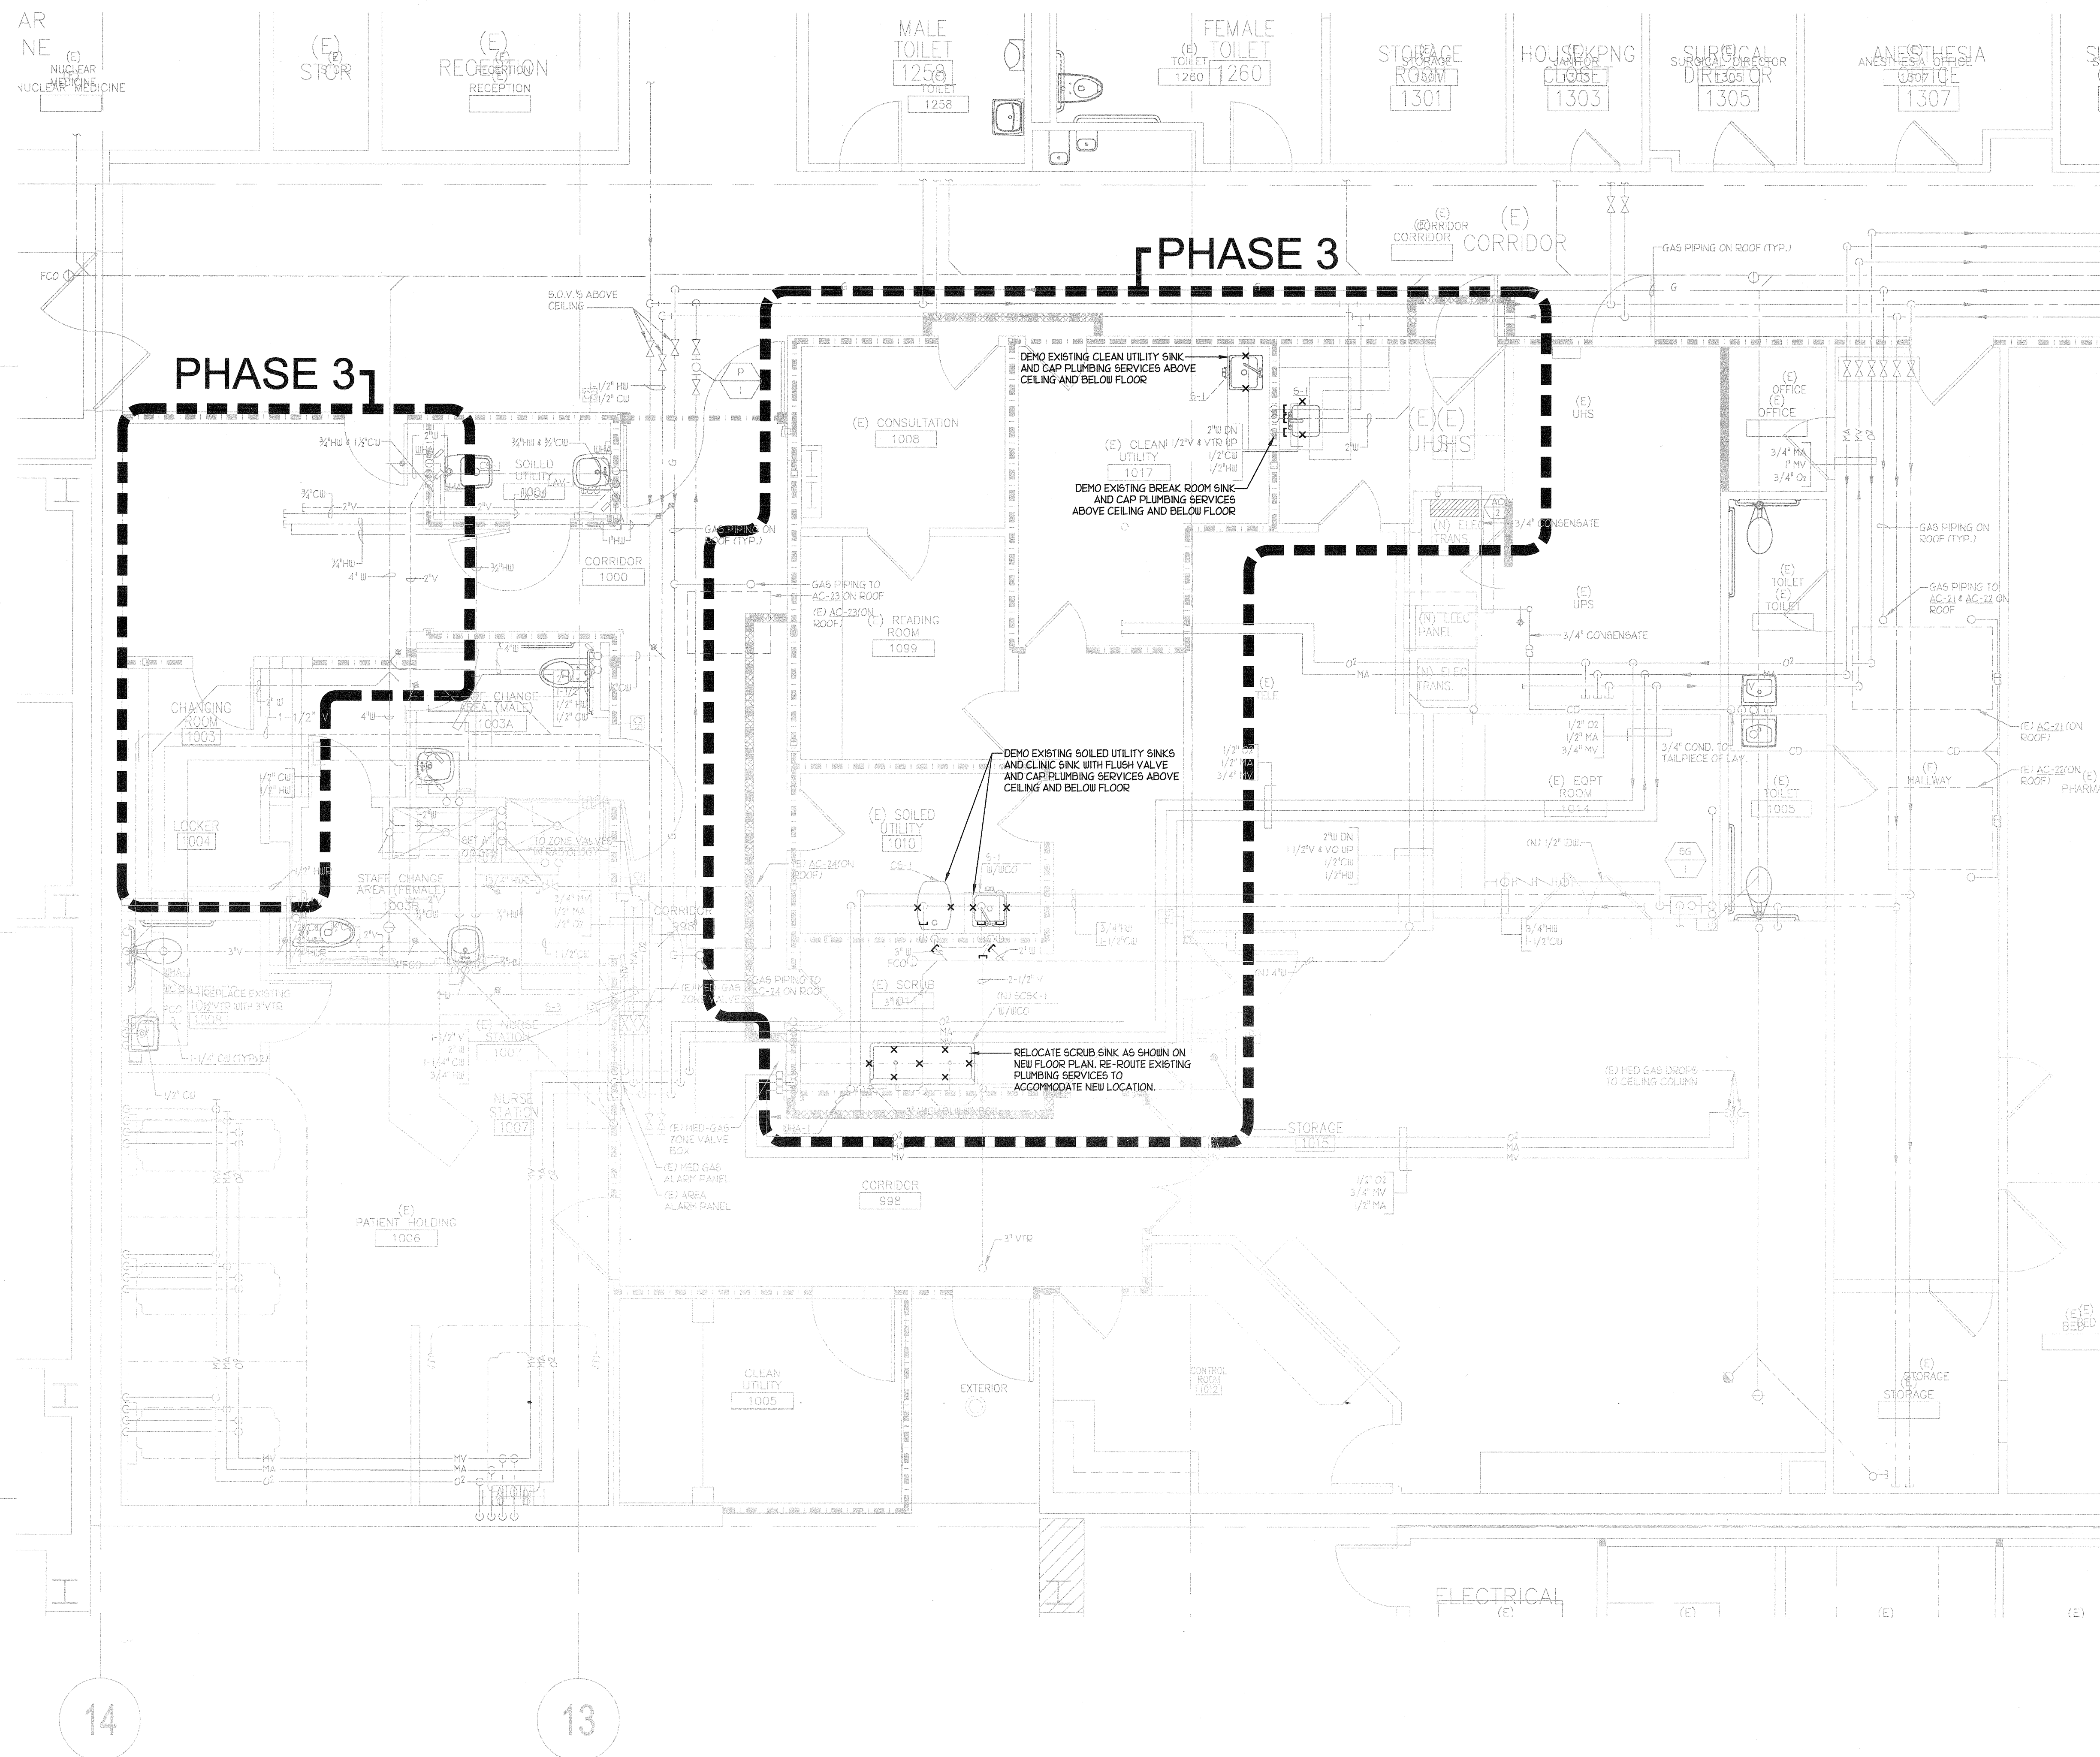

CATH LAB PLUMBING PLAN PHASE 3 - DEMOLITION

SCALE
1/4"=1'-0" 1

100% ID